

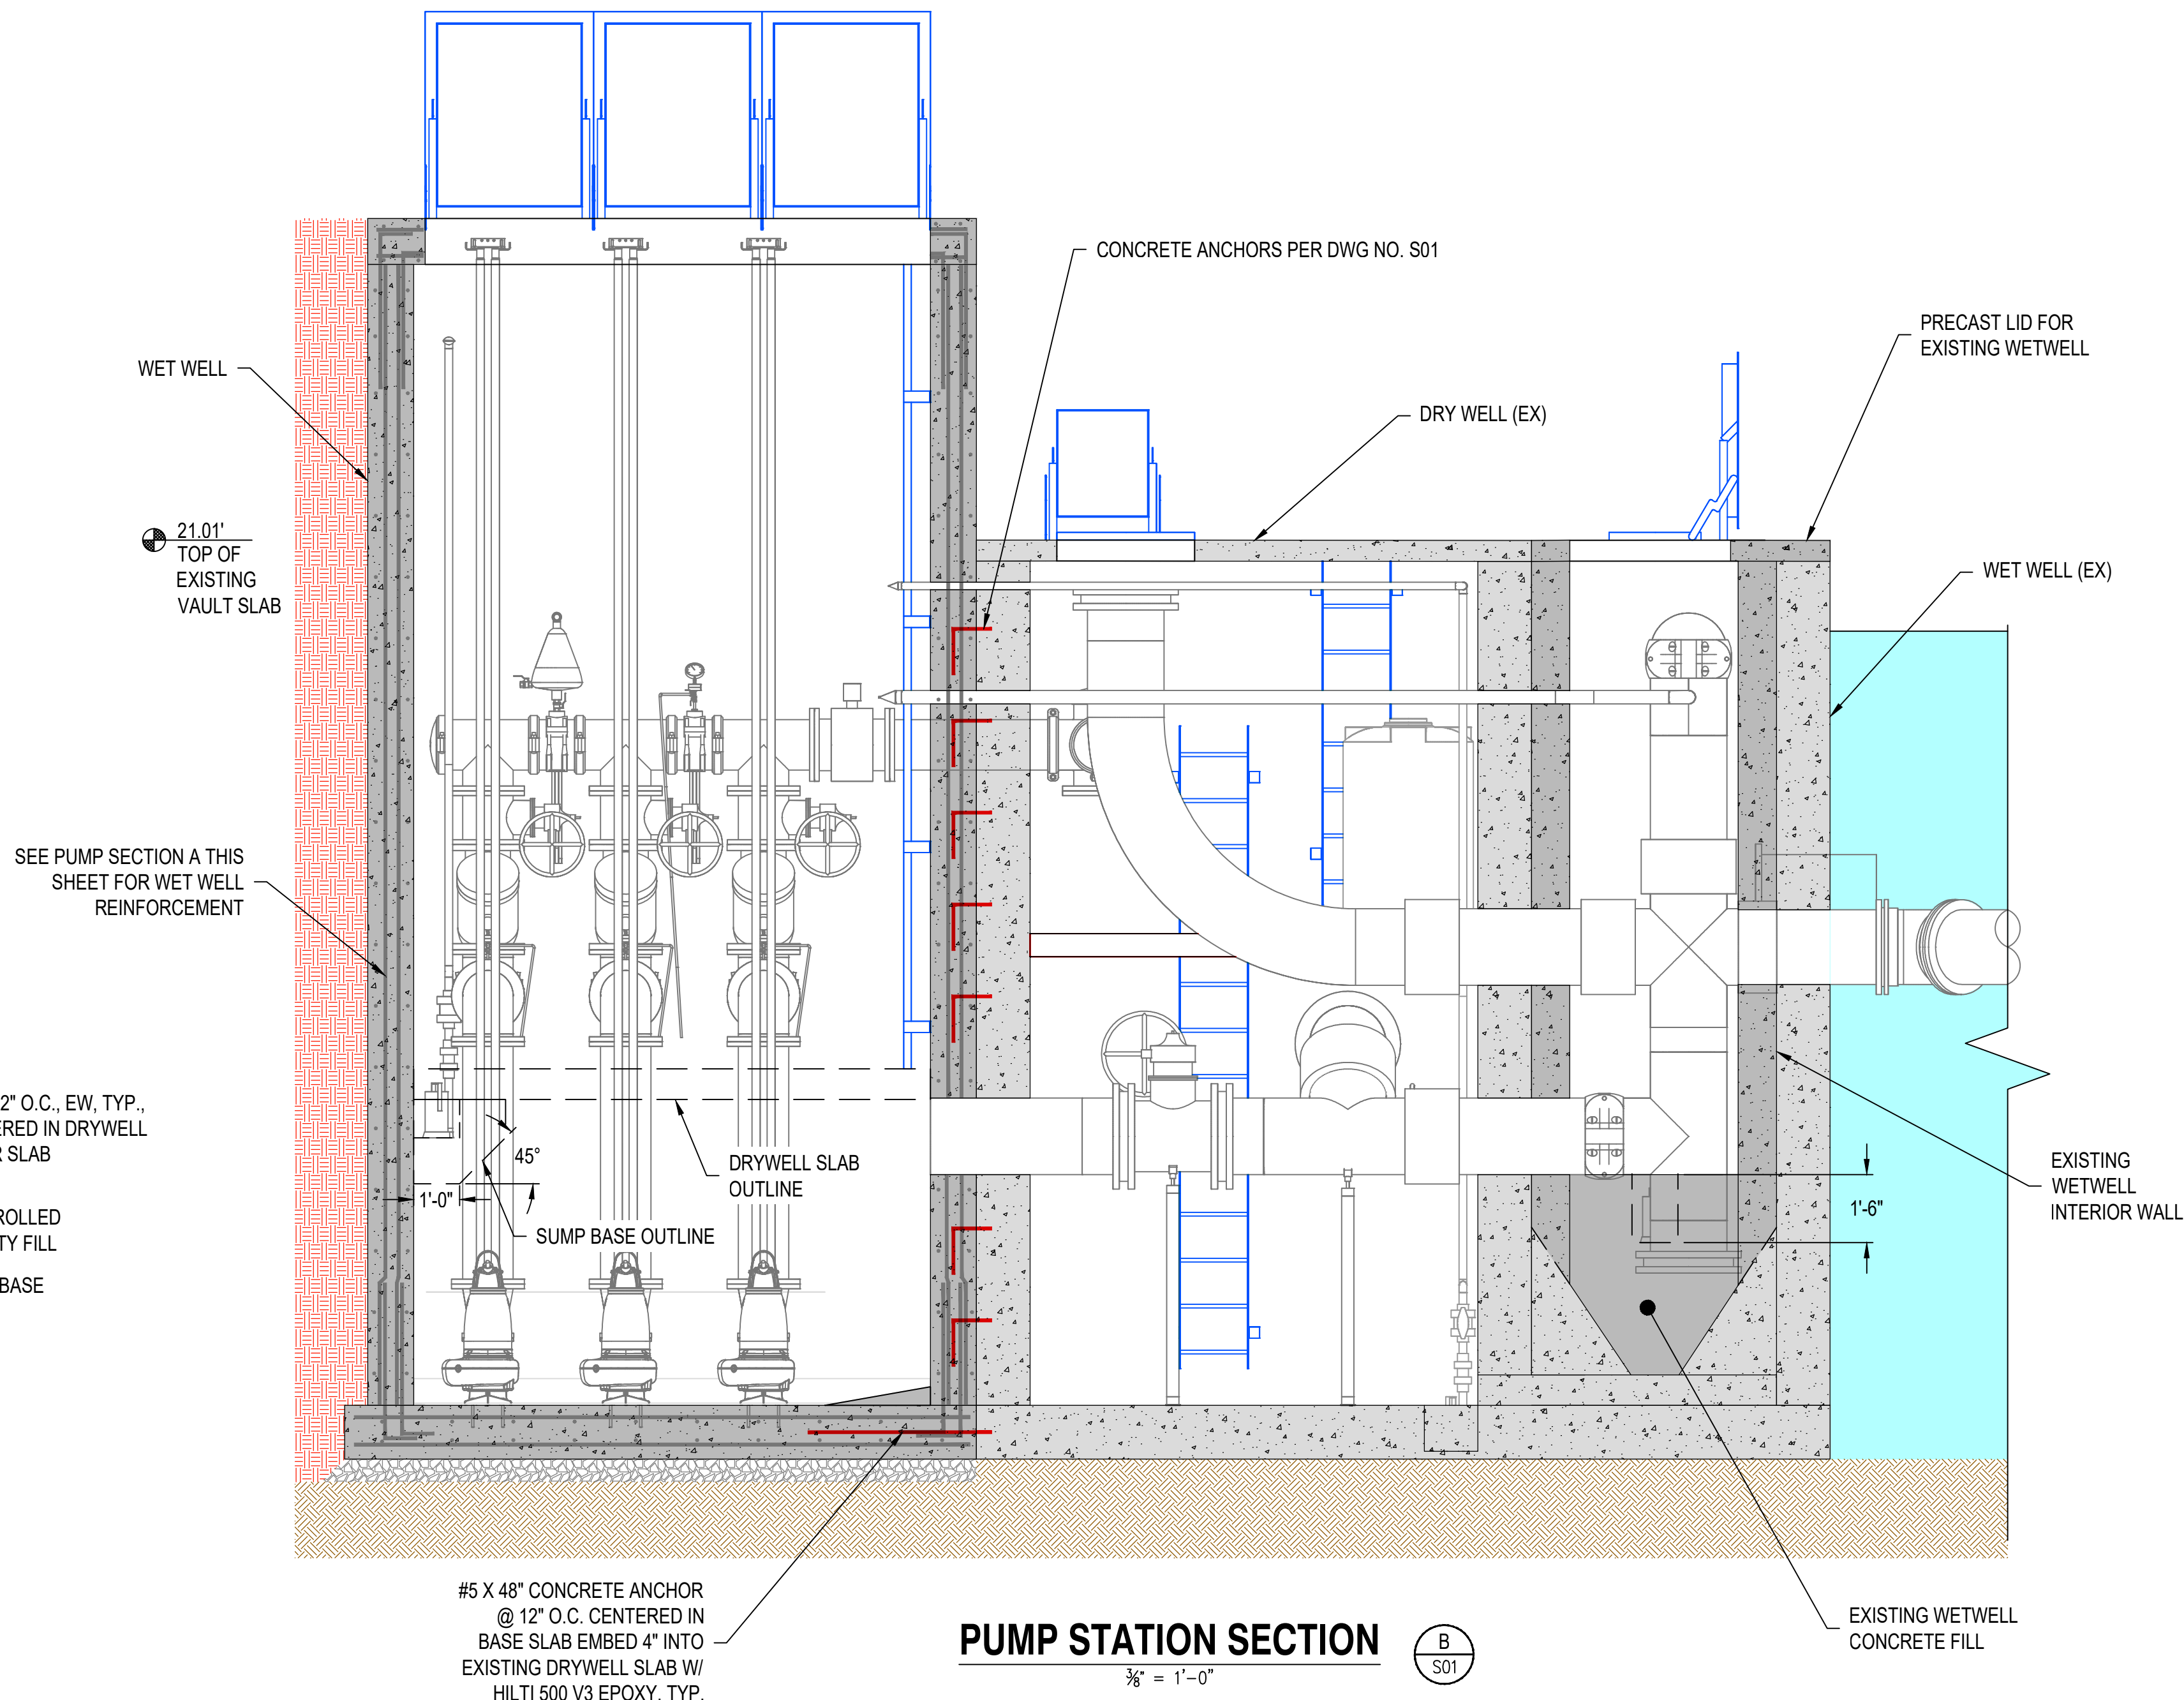


NO.	DATE	DESCRIPTION	BY	REVIEW
LOG NO.: 24-0089 CLIENT: M-I FILE NAME: LSP20-D-STRP2.DWG				
ENGINEER: TDT SAFE DATE: Aug 13, 2025 REVIEWED: JMC PLOT DATE: Aug 13, 2025				
REVISIONS PRELIMINARY				

SCALE: SHOWN	
DRAWING IS FULL SCALE WHEN BAR MEASURES 2"	
DWG NO.: S02	SHEET NO.: 22
38	

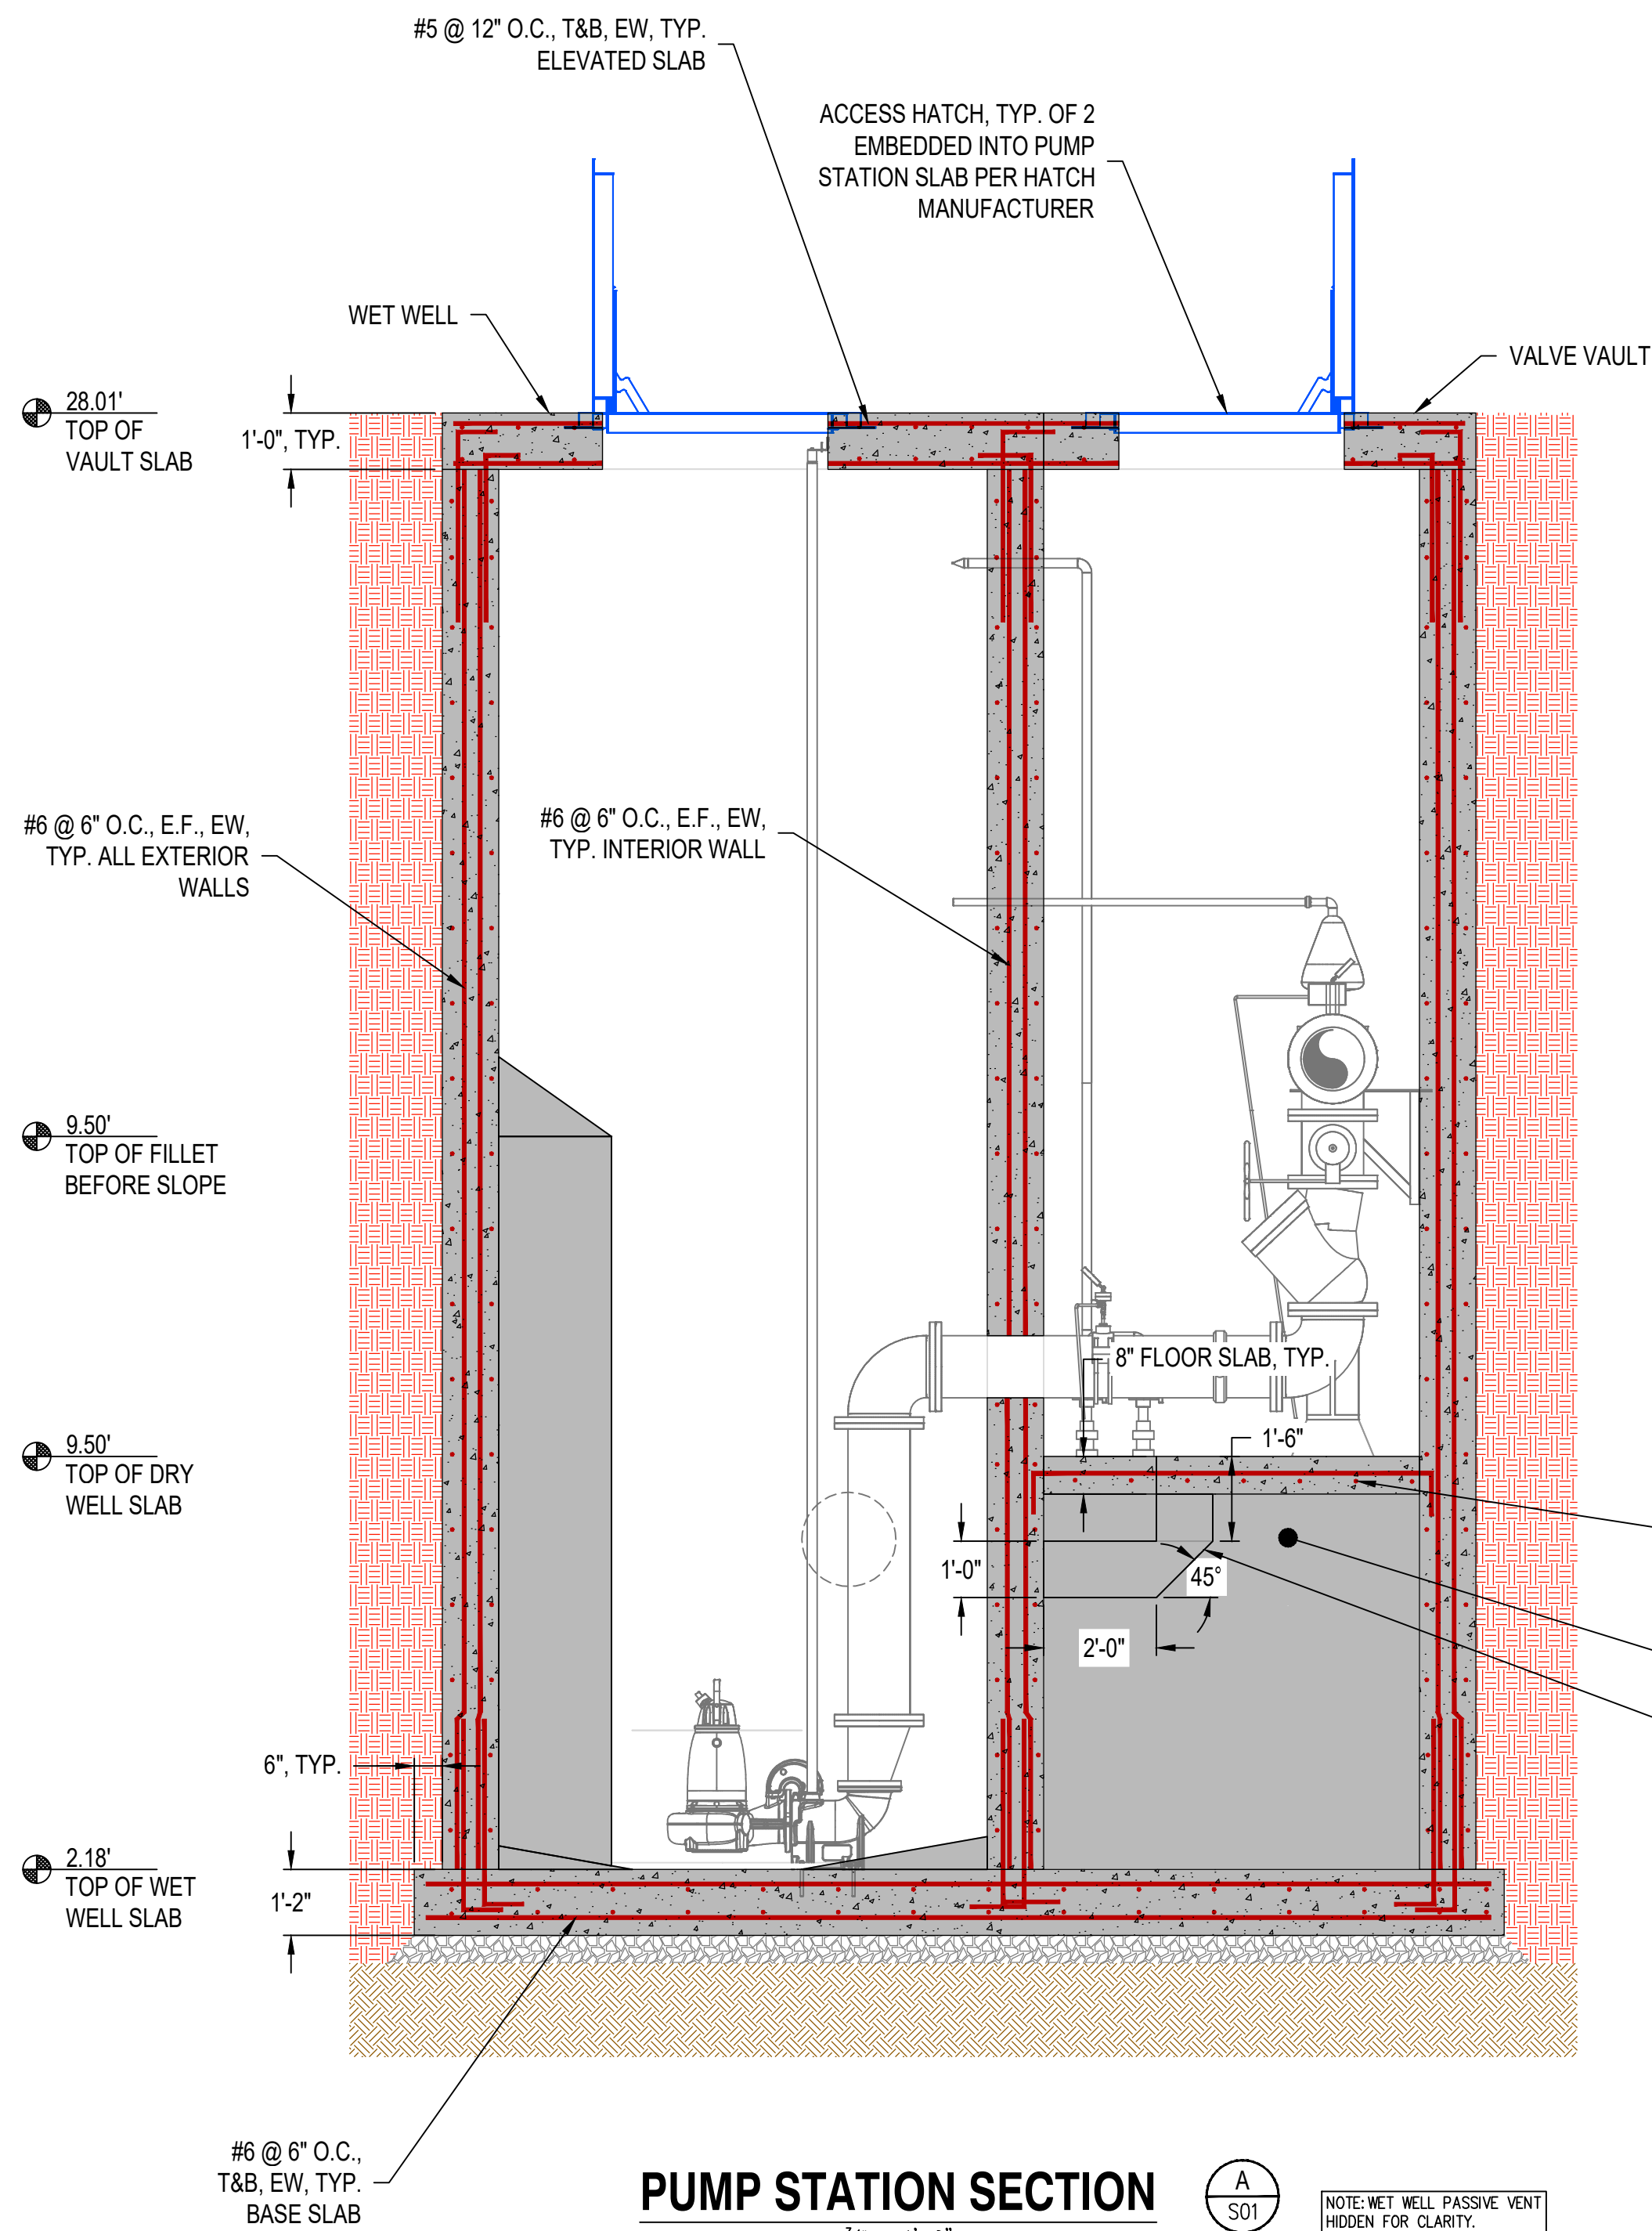

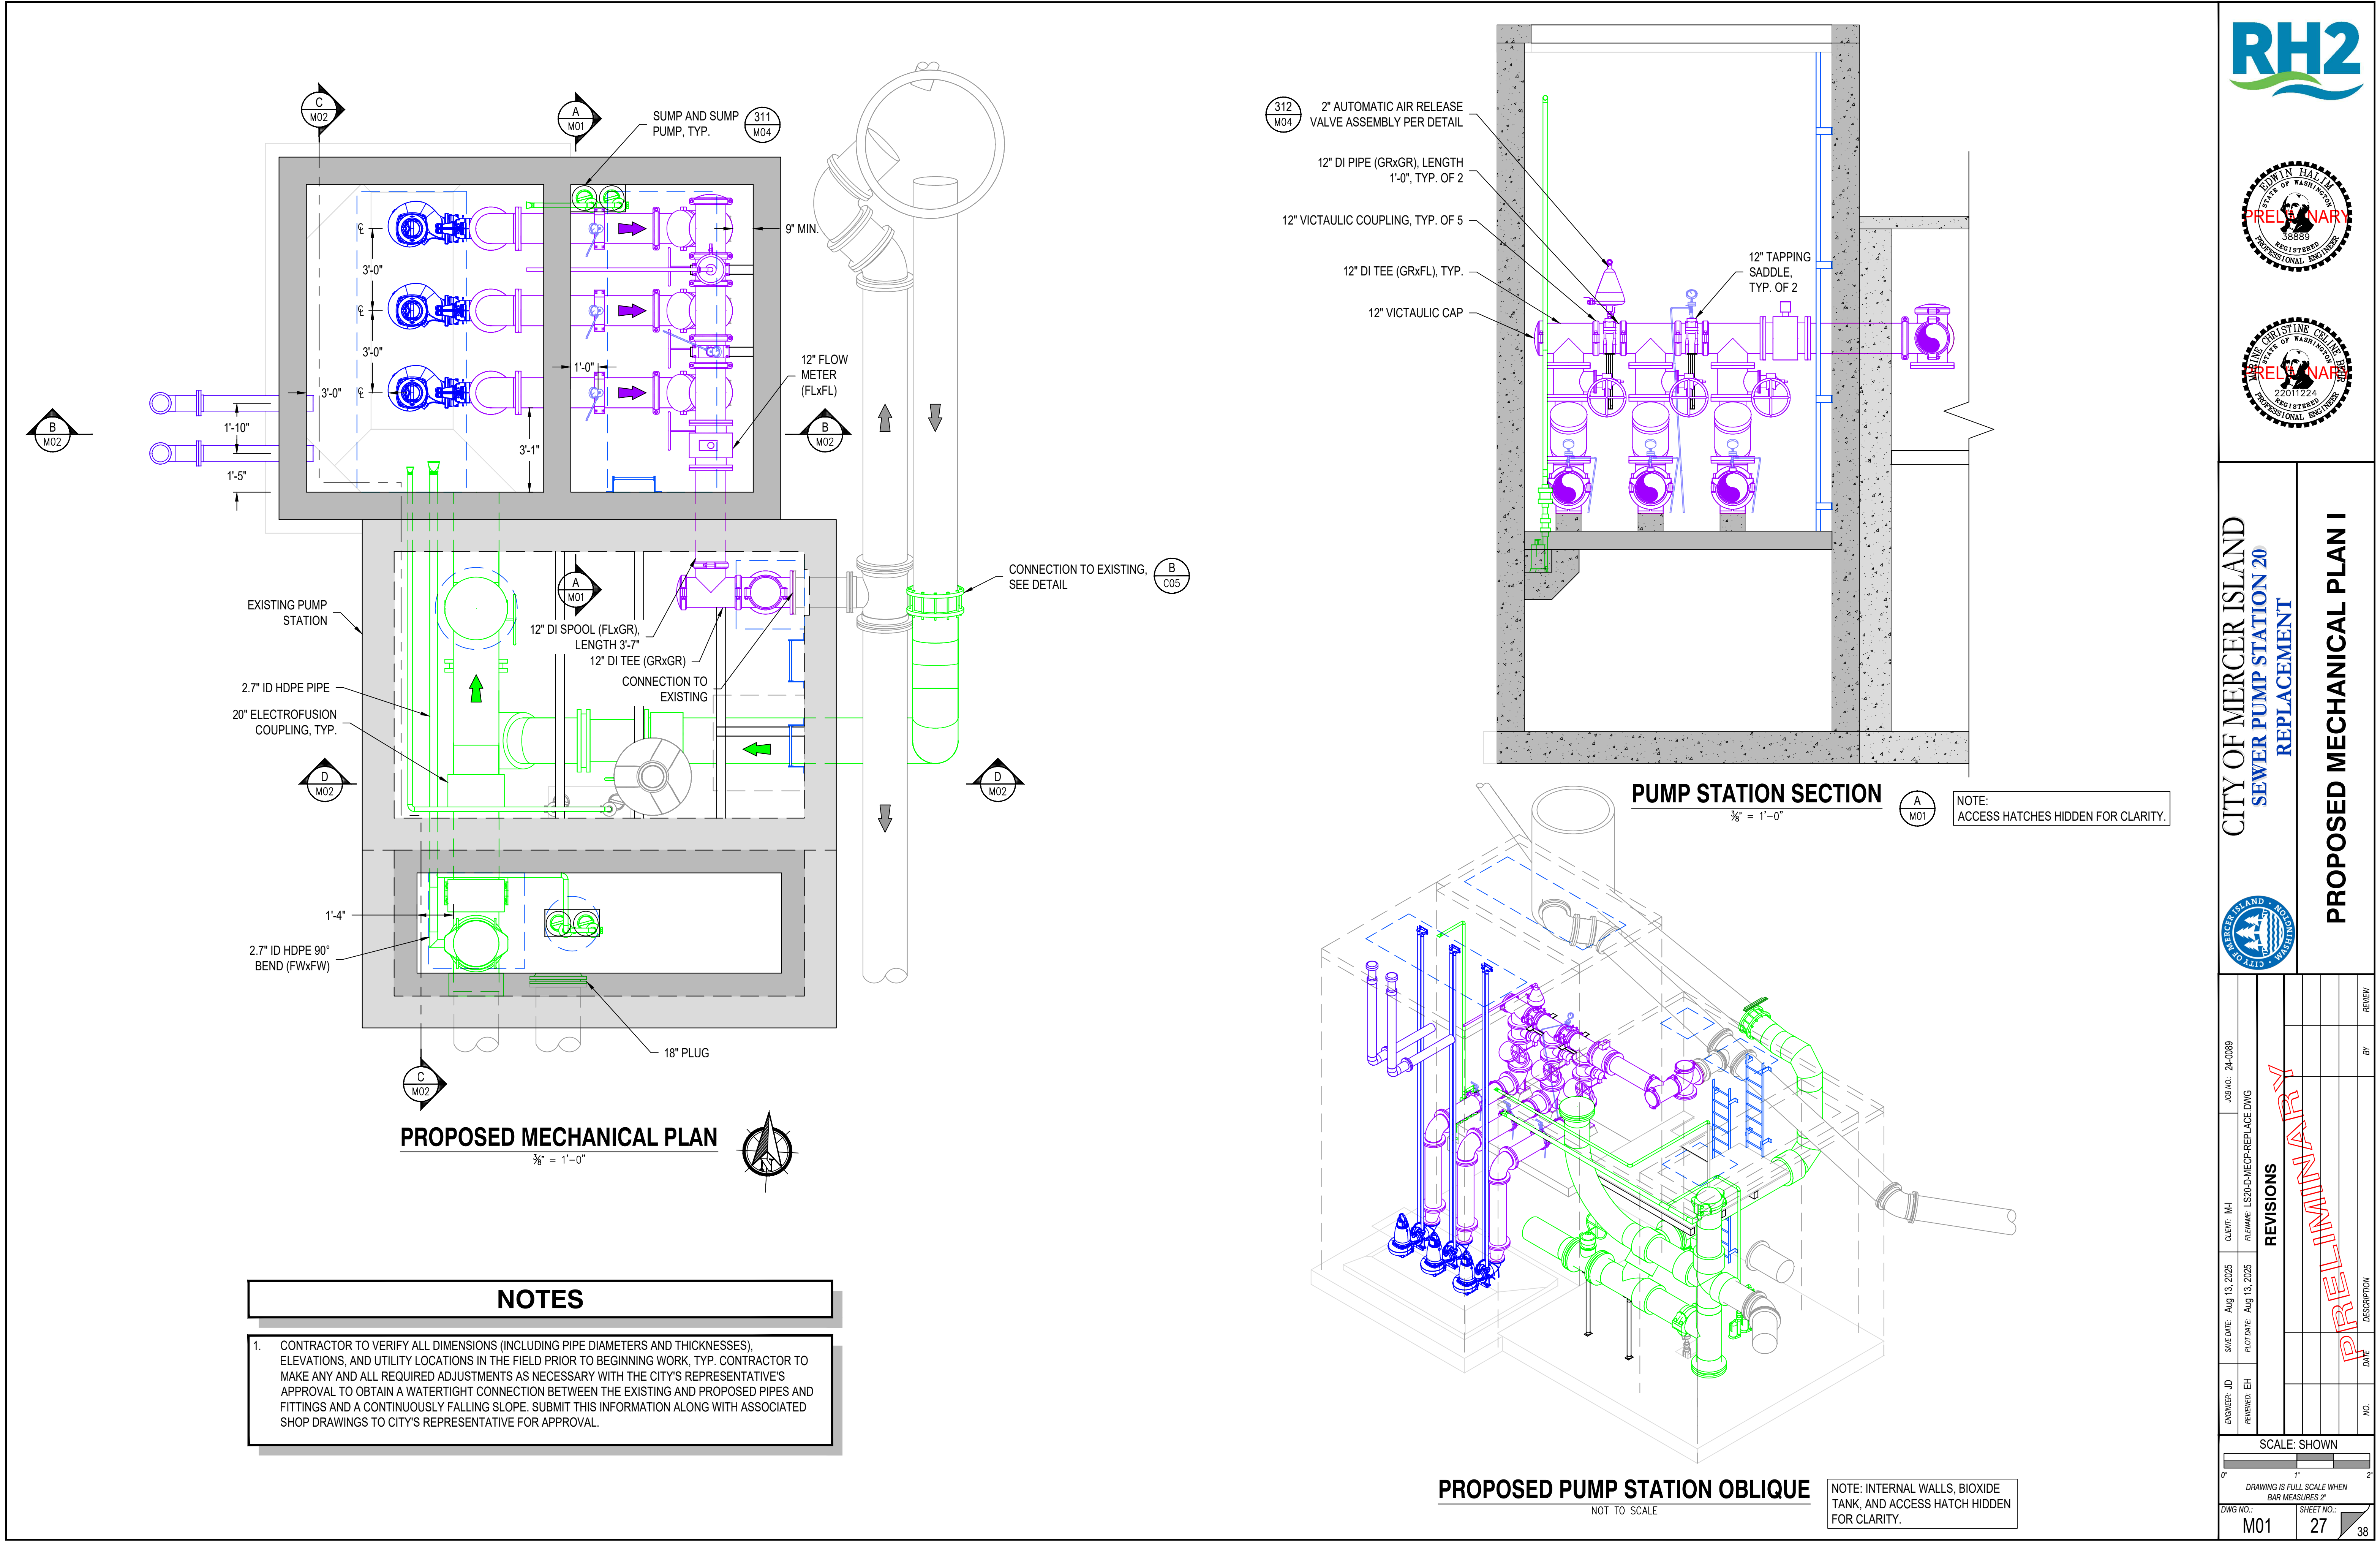

NOTES

1. CONTRACTOR TO VERIFY ALL DIMENSIONS (INCLUDING PIPE DIAMETERS AND THICKNESSES), ELEVATIONS, AND UTILITY LOCATIONS IN THE FIELD PRIOR TO BEGINNING WORK, TYP. CONTRACTOR TO MAKE ANY AND ALL REQUIRED ADJUSTMENTS AS NECESSARY WITH THE CITY'S REPRESENTATIVE'S APPROVAL TO OBTAIN A WATERTIGHT CONNECTION BETWEEN THE EXISTING AND PROPOSED PIPES AND FITTINGS AND A CONTINUOUSLY FALLING SLOPE. SUBMIT THIS INFORMATION ALONG WITH ASSOCIATED SHOP DRAWINGS TO CITY'S REPRESENTATIVE FOR APPROVAL.

CITY OF MERCER ISLAND
SEWER PUMP STATION 20 REPLACEMENT

CITY OF MERCER ISLAND

ENGINEER: JD	DATE: Aug 13, 2025	CLIENT: M-I	LOG NO.: 24-0089
REVIEWED: EH	PLOT DATE: Aug 13, 2025	FILENAME: LS20-D-MECP-REPLACE.DWG	
REVISIONS			
NO.	DATE	DESCRIPTION	BY
			REVIEW

SCALE: SHOWN

0" 1" 2"




DRAWING IS FULL SCALE WHEN BAR MEASURES 2"

DWG NO.: M01

SHEET NO.: 27

38

PROPOSED MECHANICAL PLAN I

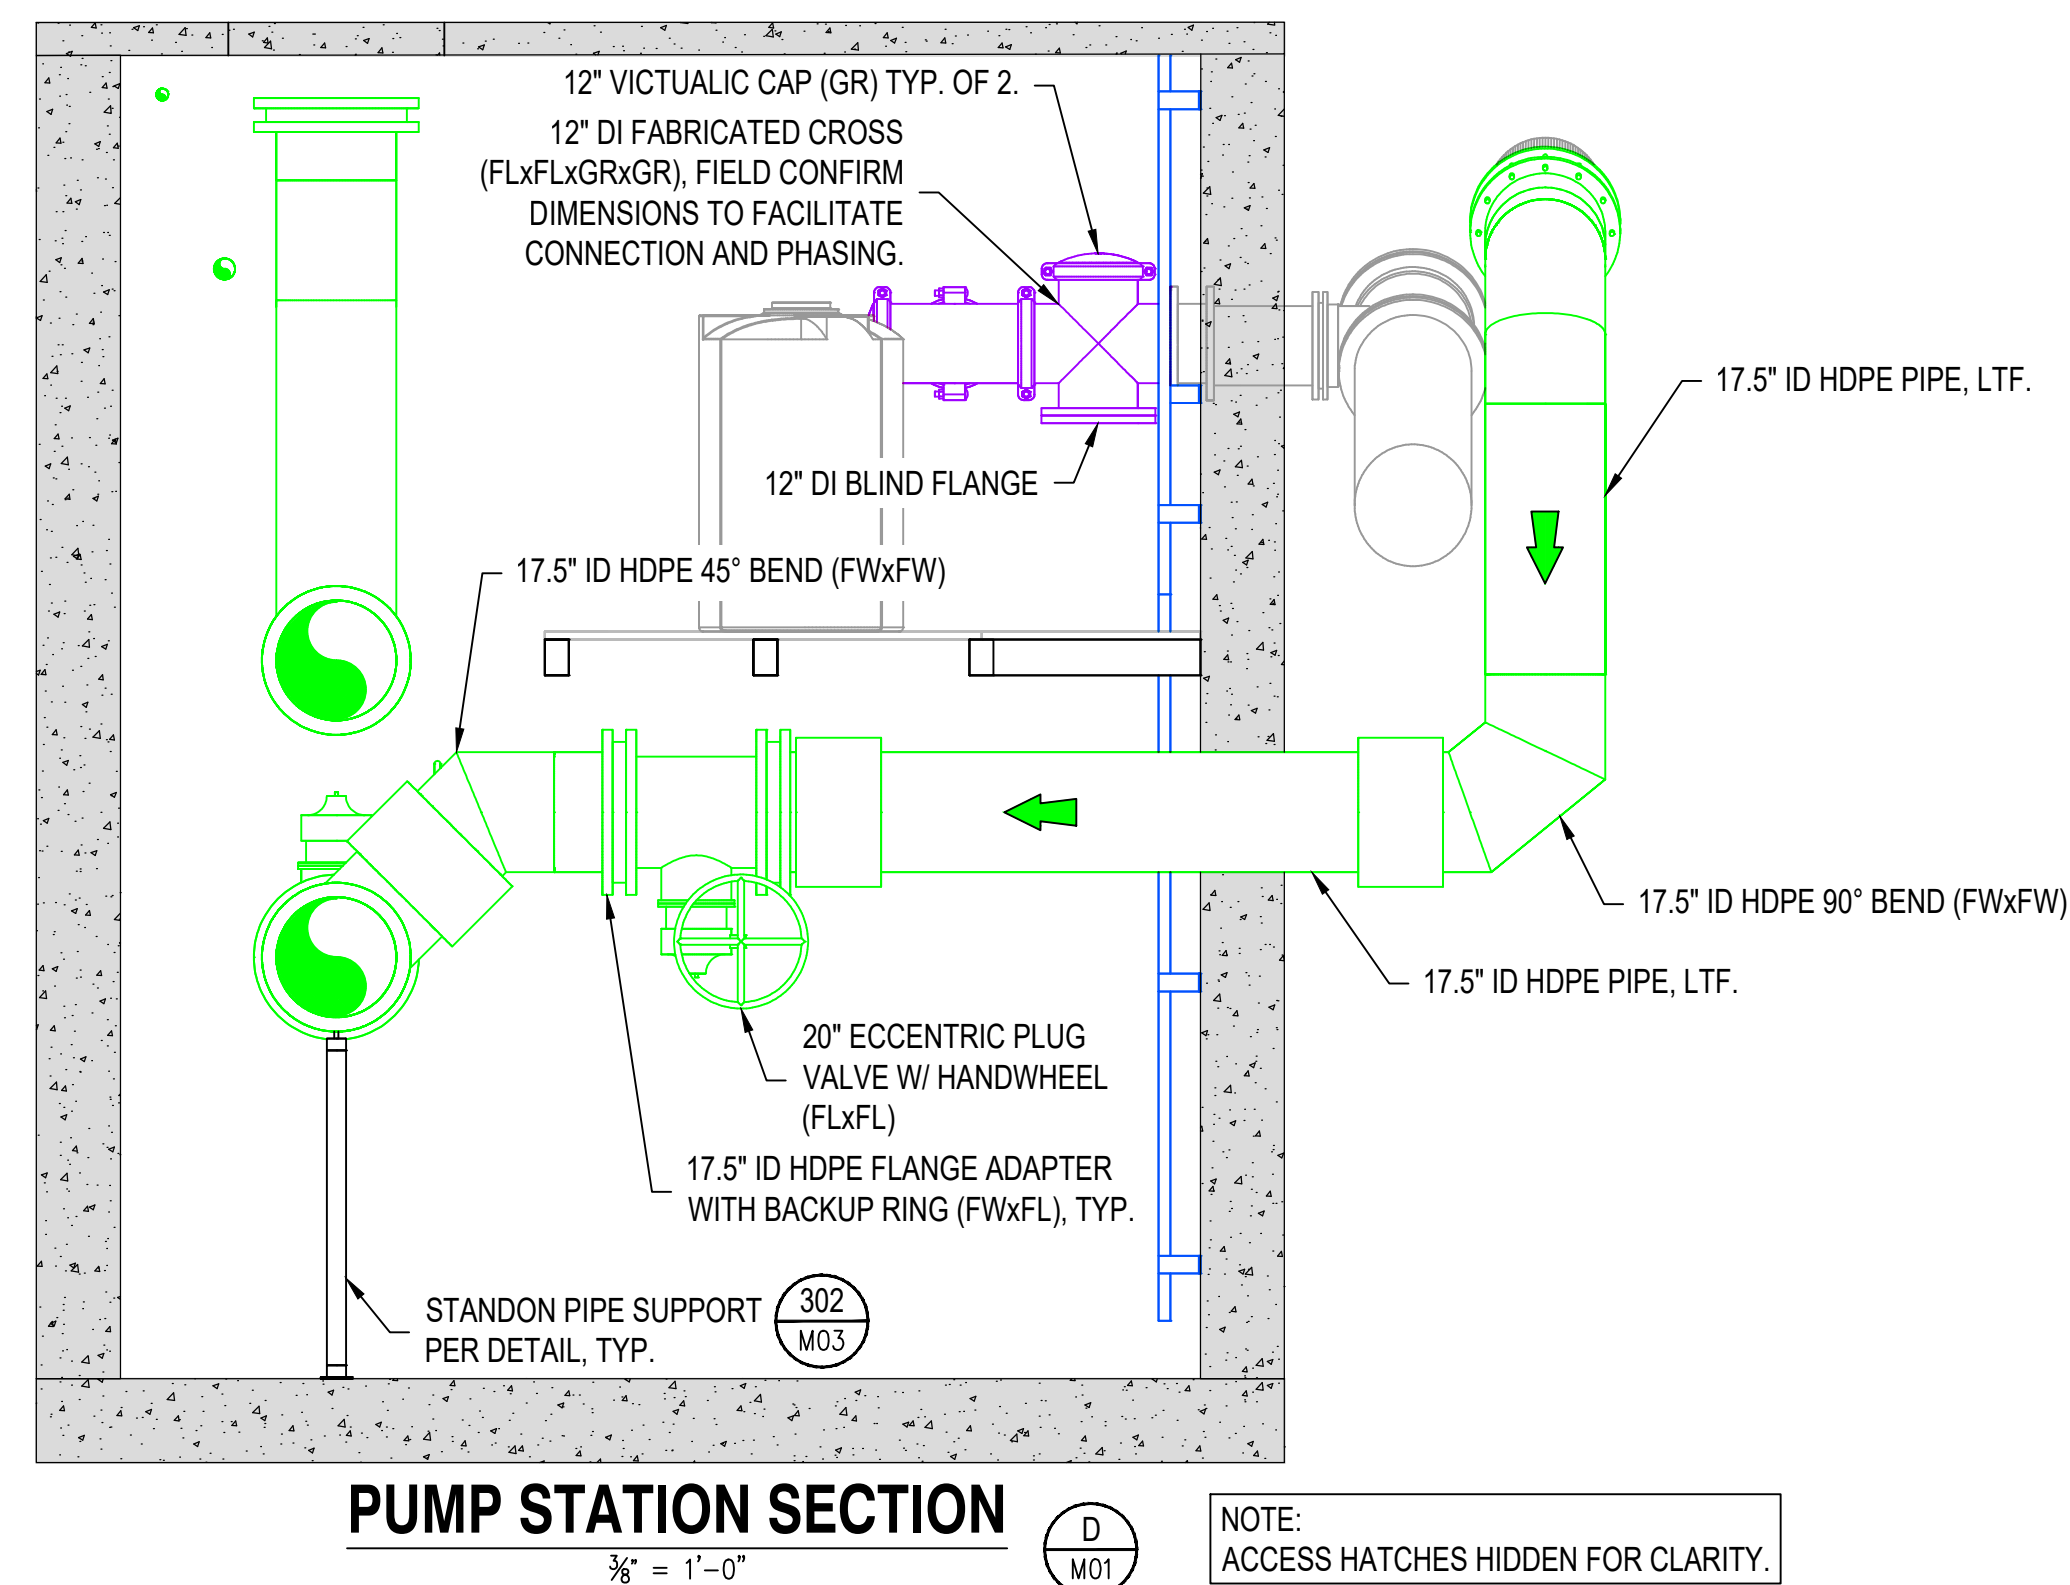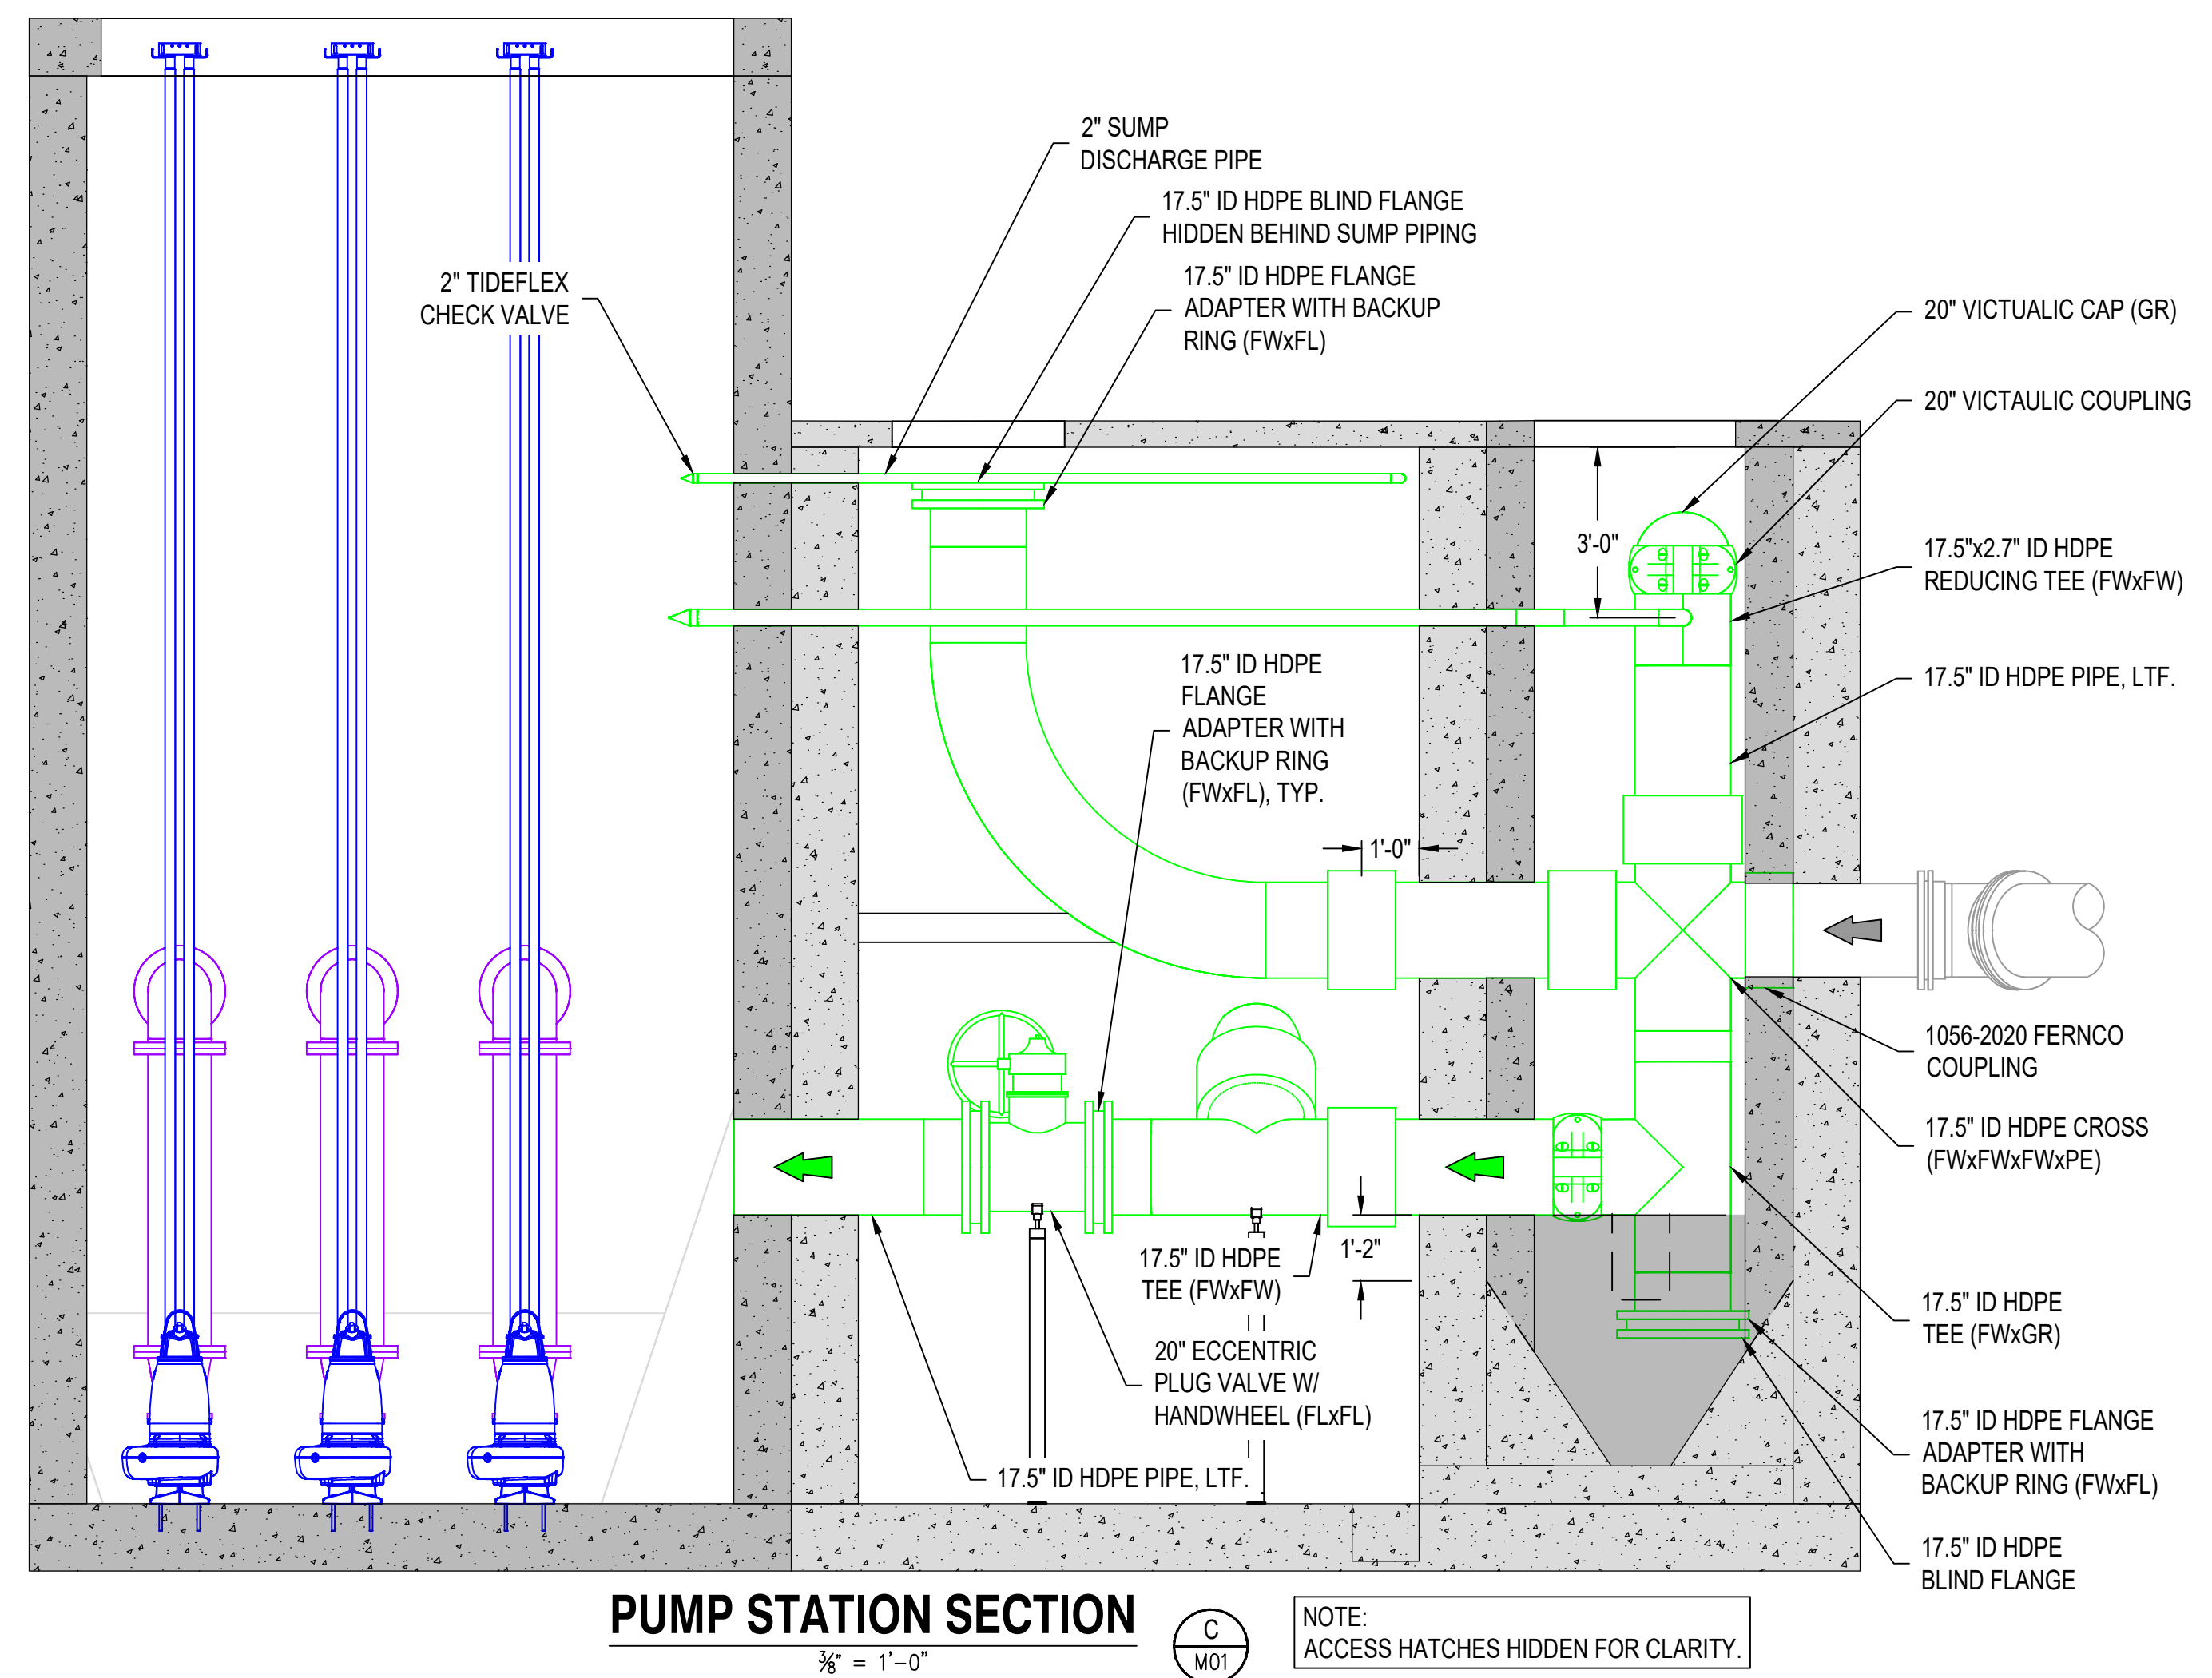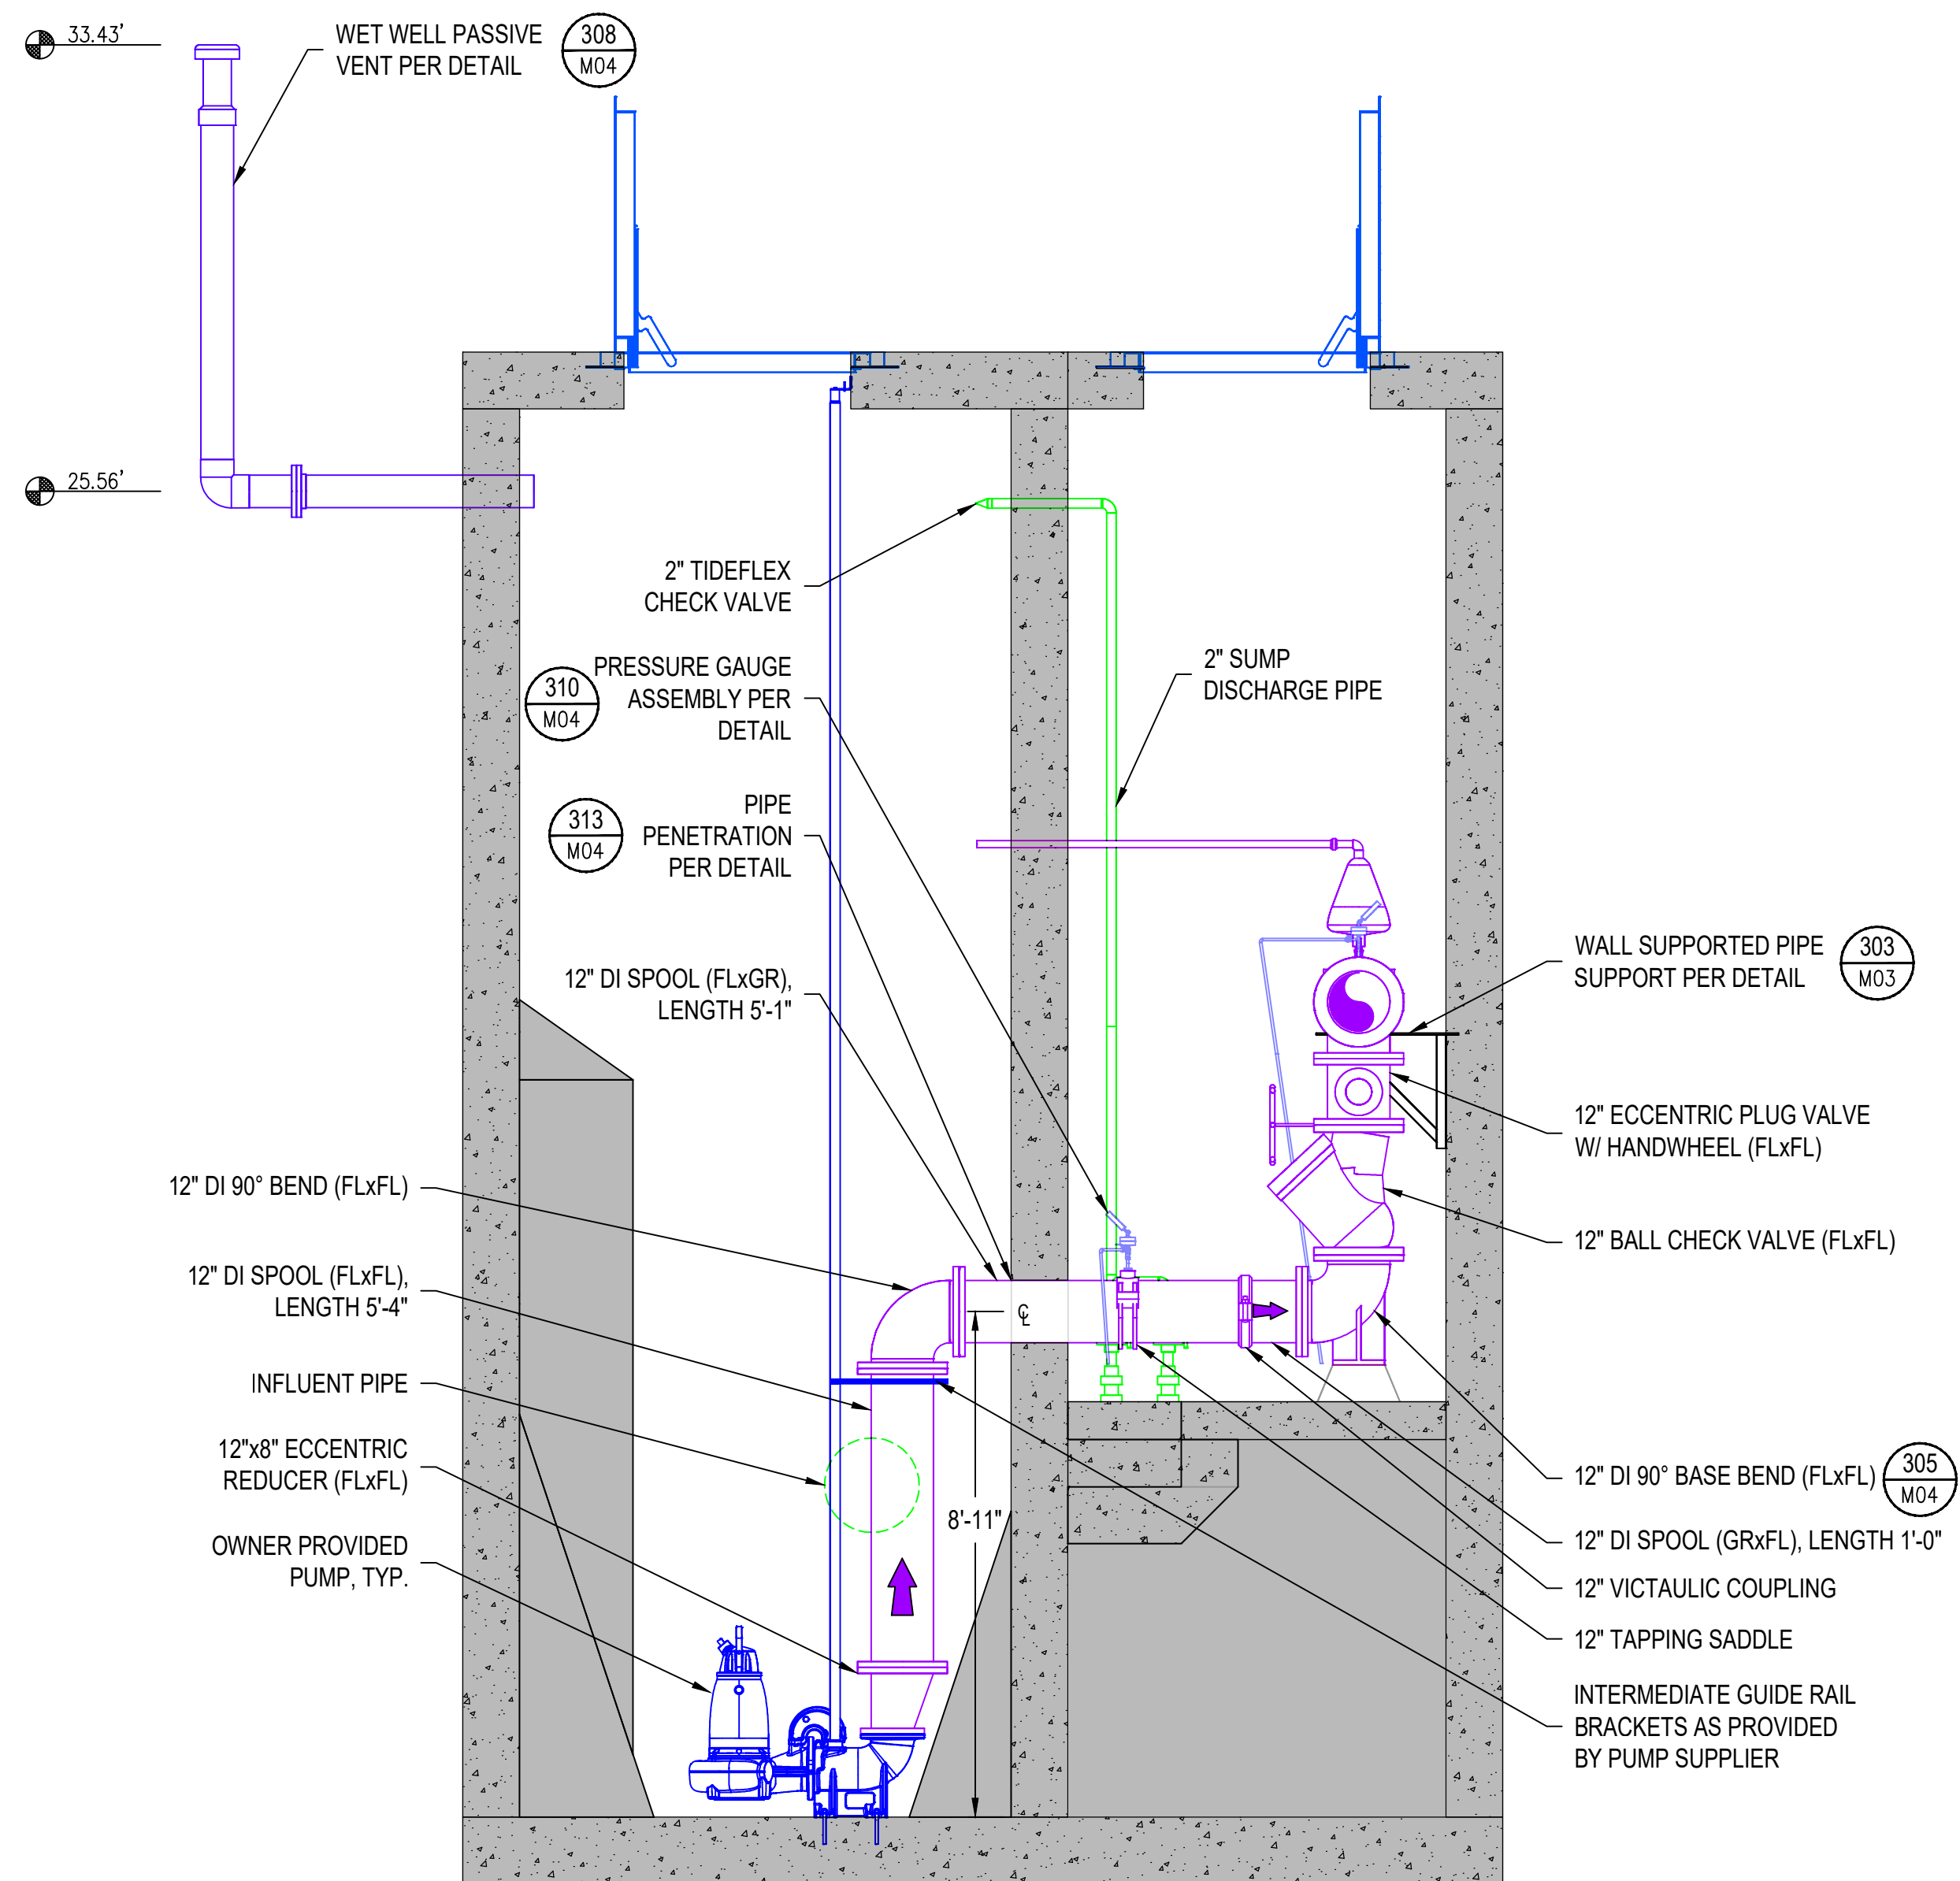

1. CONTRACTOR TO VERIFY ALL DIMENSIONS (INCLUDING PIPE DIAMETERS AND THICKNESSES), ELEVATIONS, AND UTILITY LOCATIONS IN THE FIELD PRIOR TO BEGINNING WORK, TYP. CONTRACTOR TO MAKE ANY AND ALL REQUIRED ADJUSTMENTS AS NECESSARY WITH THE CITY'S REPRESENTATIVE'S APPROVAL TO OBTAIN A WATERTIGHT CONNECTION BETWEEN THE EXISTING AND PROPOSED PIPES AND FITTINGS. SUBMIT THIS INFORMATION ALONG WITH ASSOCIATED SHOP DRAWINGS TO CITY'S REPRESENTATIVE FOR APPROVAL.